






NOTES:

1. ALL FLANGED JOINTS SHALL BE PROVIDED WITH ONE GROUNDING JUMPER PER EACH PAIR OF FLANGES PER DETAIL M-3574.
2. ALL "AIR SAVER" LOCATIONS SHALL BE PROVIDED WITH AN "AIR SAVER" CONNECTION PER DETAIL D/M-05. NOMINAL "AIR SAVER" SPACING SHALL BE 5 FT., AND/OR AS OTHERWISE SHOWN. CONTRACTOR SHALL DRILL AND DEBUR "AIR SAVER" CONNECTIONS PER MANUFACTURER REQUIREMENTS.
3. CONNECT NEW PIPING TO EXISTING EQUIPMENT WHERE SHOWN. COORDINATE WITH EQUIPMENT CONFIGURATION AND MANUFACTURER REQUIREMENTS AND RECOMMENDATIONS.
4. DIMENSIONS TO FLANGES ARE TO INSIDE FACE OF FLANGE. DIMENSIONS TO COUPLINGS ARE TO CENTER OF COUPLING.
5. CONTRACTOR SHALL PROVIDE ALL MATERIALS AND COMPONENTS DIRECTLY NOT INDICATED BELOW FROM IDENTIFIED VENDOR. PROVIDE SCH. 40 STEEL PIPE, FLANGE HARDWARE, GASKETS, COPPER PIPE AND FITTINGS, ALL SUPPORTS AND ALL OTHER ELEMENTS SHOWN ON THE DRAWINGS OR OTHERWISE REQUIRED. PROVIDE PIPING TO REQUIRED LENGTHS AND WELD FLANGES AND COUPLING RINGS TO MANUFACTURER REQUIREMENTS.
6. ALL STEEL PIPING CUTTING, WELDING AND FABRICATING SHALL BE SHOP PERFORMED, EXCEPT AS REQUIRED FOR FINAL FIELD ADJUSTMENT. NO STEEL PIPE TORCH CUTTING, POWER CUTTING, WELDING OR FABRICATING SHALL OCCUR WITHIN 50 FT. OF ANY PORTION OF THE THERMAL DRYING FACILITY WHICH IS A NEC CLASS 1, DIV. 2 AREA.
7. NOT USED.
8. CONTRACTOR SHALL PURCHASE "AIR SAVERS" AND ACCUTREMENTS, "SUPERSLIK" FITTINGS, "END RECEIVERS" AND "TUF-LOC" COUPLINGS FROM DYNAMIC AIR, INC., ST. PAUL, MN. COORDINATE REQUIREMENTS, MATERIALS AND RELATED ITEMS WITH THIS SUPPLIER AS REQUIRED AND INSTALL PER MANUFACTURER RECOMMENDATIONS.
9. "AIR SAVER" PRESSURE SETTINGS SHALL BE AS GIVEN IN THE SCHEDULE.
10. CONTRACTOR SHALL FURNISH FLANGE HARDWARE FOR "SUPER SLIK" FITTINGS AS GIVEN IN THE SCHEDULE.
11. PROVIDE PIPE SUPPORTS OF THE TYPE AND LOCATION REQUIRED WHERE SHOWN BY AN "X" OR OTHERWISE INDICATED OR SPECIFIED. MAXIMUM UNSUPPORTED SPAN OF 3" DIA. SCHEDULE 40 STEEL PIPING SHALL BE 12 FT. MAXIMUM UNSUPPORTED SPAN OF 1" AND 3/4" DIA. TYPE K RIGID COPPER PIPE SHALL BE 6 FT.

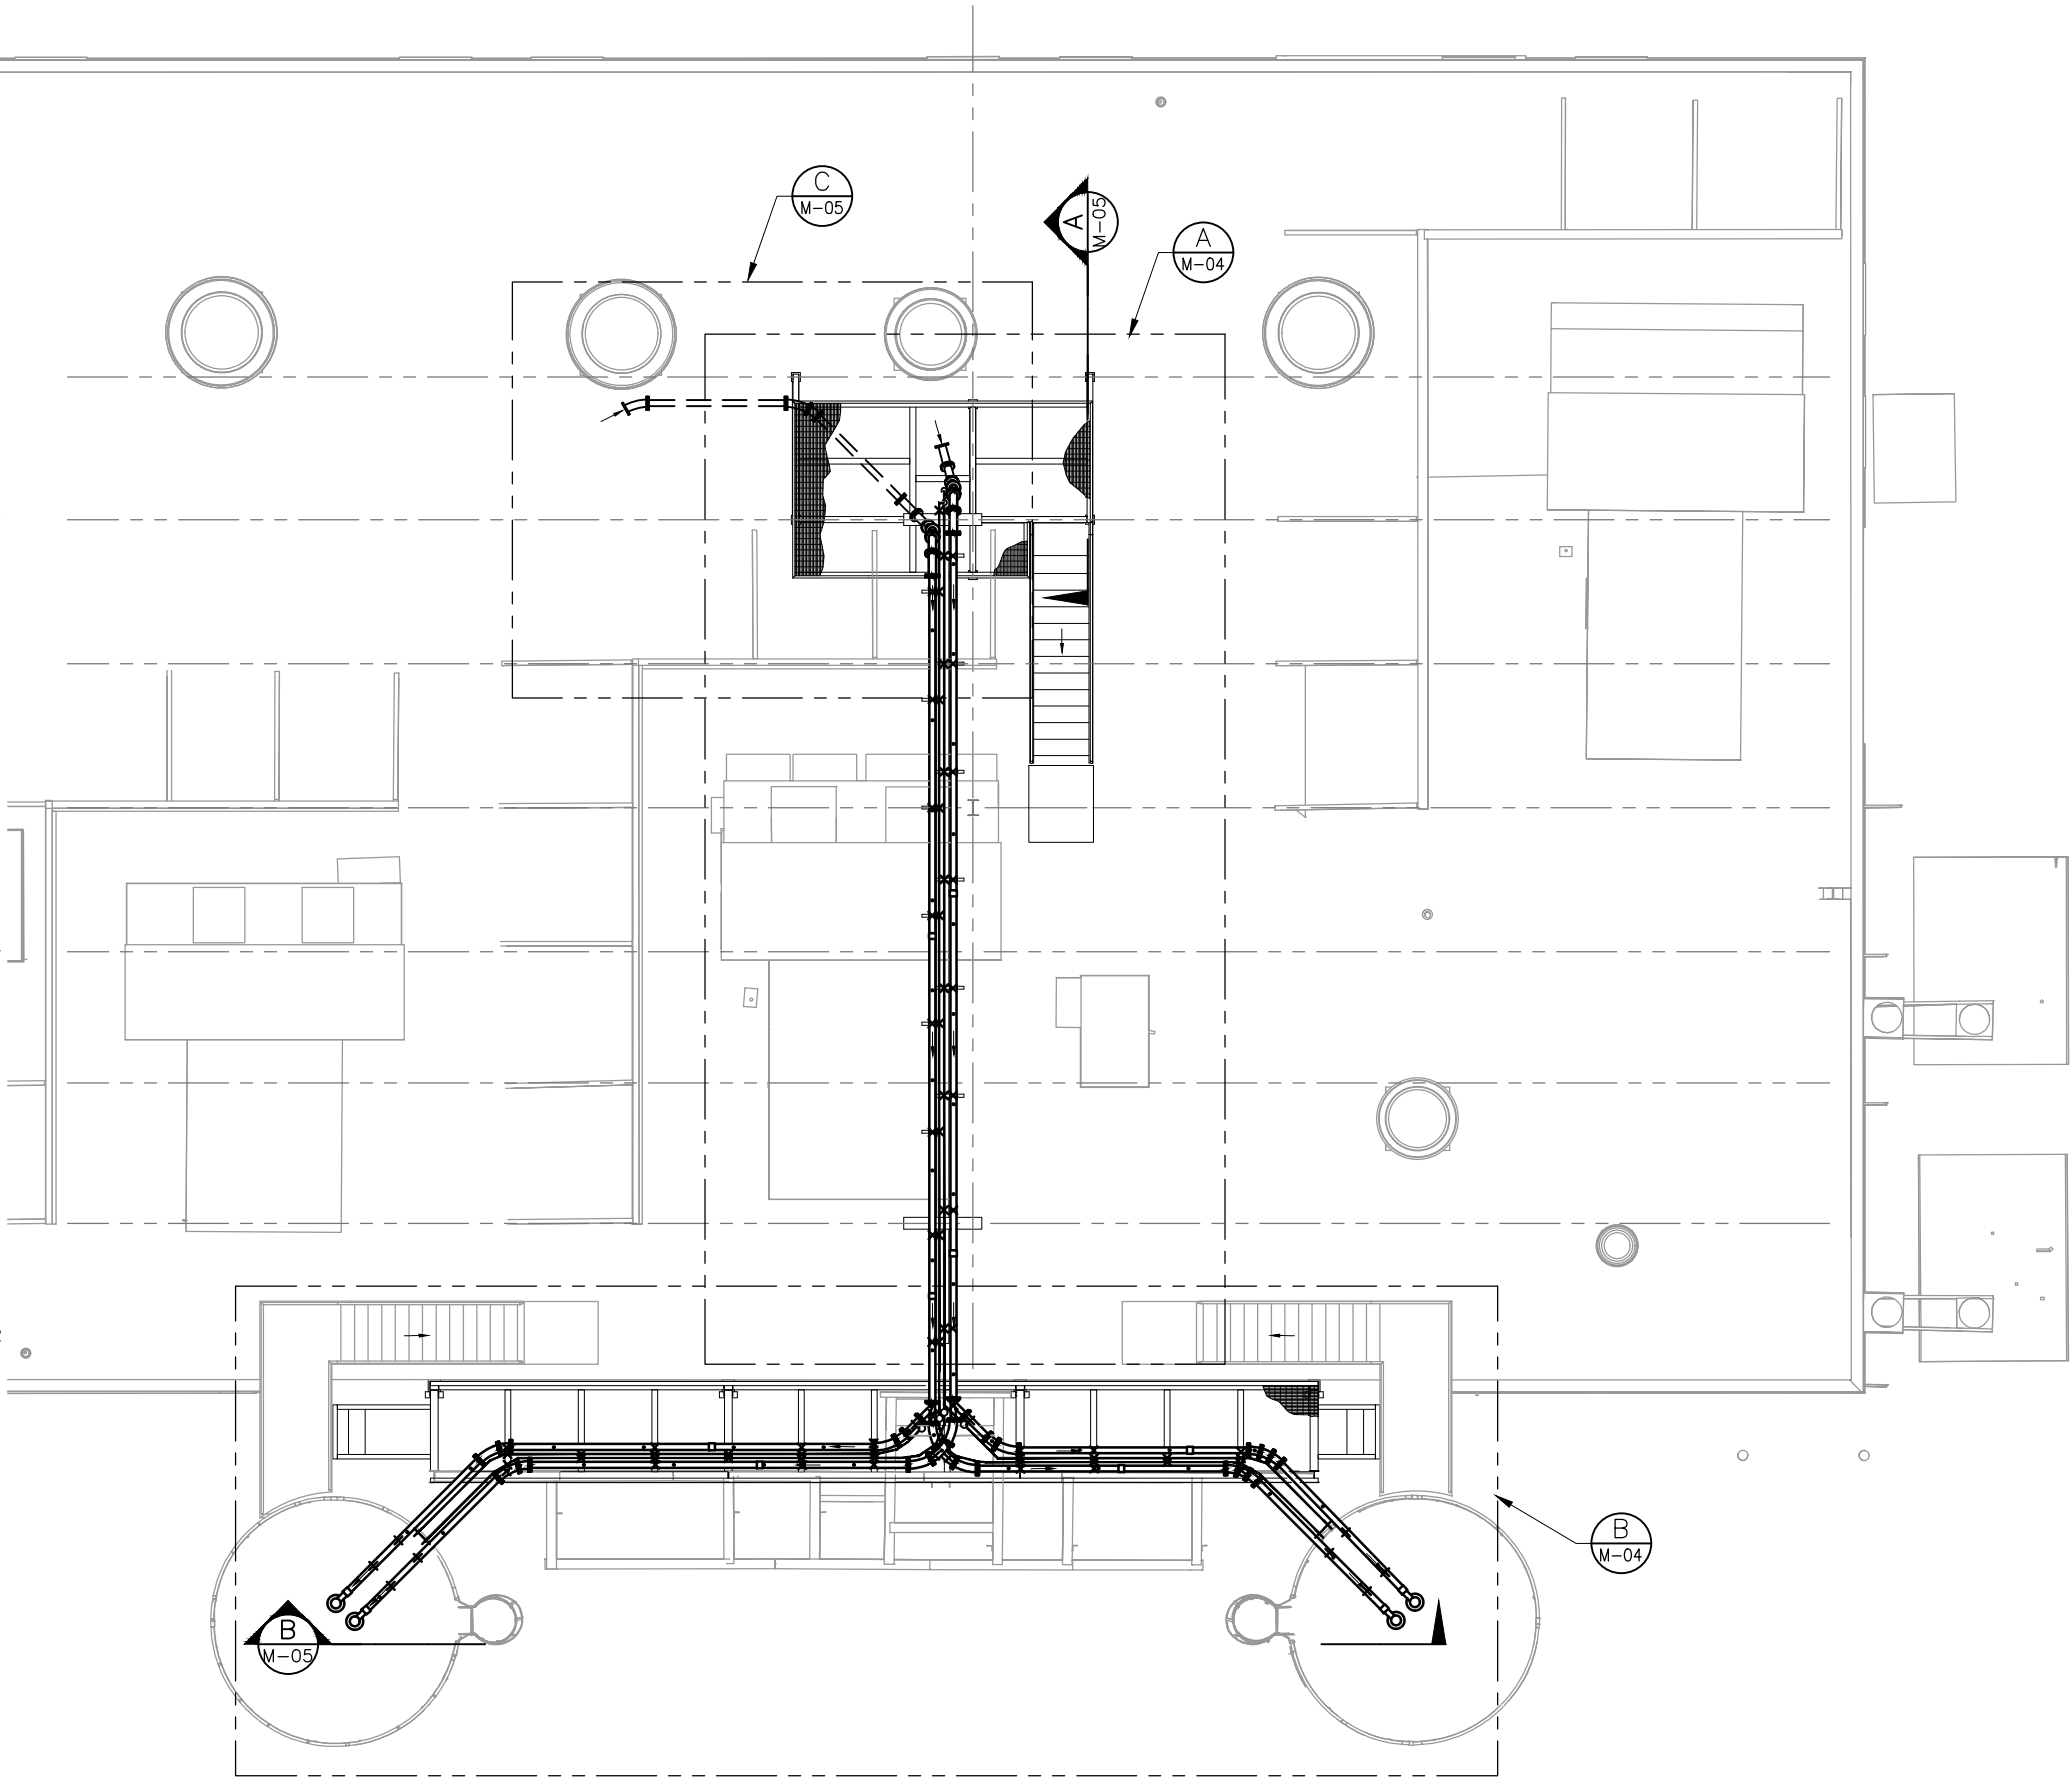

PLAN

SCALE: 1/8" = 1'-0"

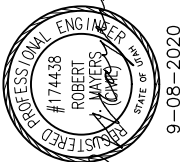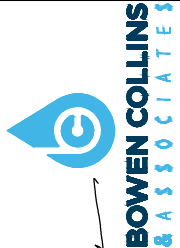

REVISIONS			
NO.	DATE	REV. BY	DESCRIPTION

VERIFY SCALE	
BAR IS ONE INCH ON ORIGINAL DRAWING	


REVIEW	
CHECKED B. MAYERS	APPROVED B. MAYERS

DESIGN	
DESIGN D. COWELL	DRAWN T. ANDERSON

PROJECT NUMBER	
177-17-01.02	

DATE: SEPTEMBER 2020	
----------------------	--

DRAWING NO.	
M-03	

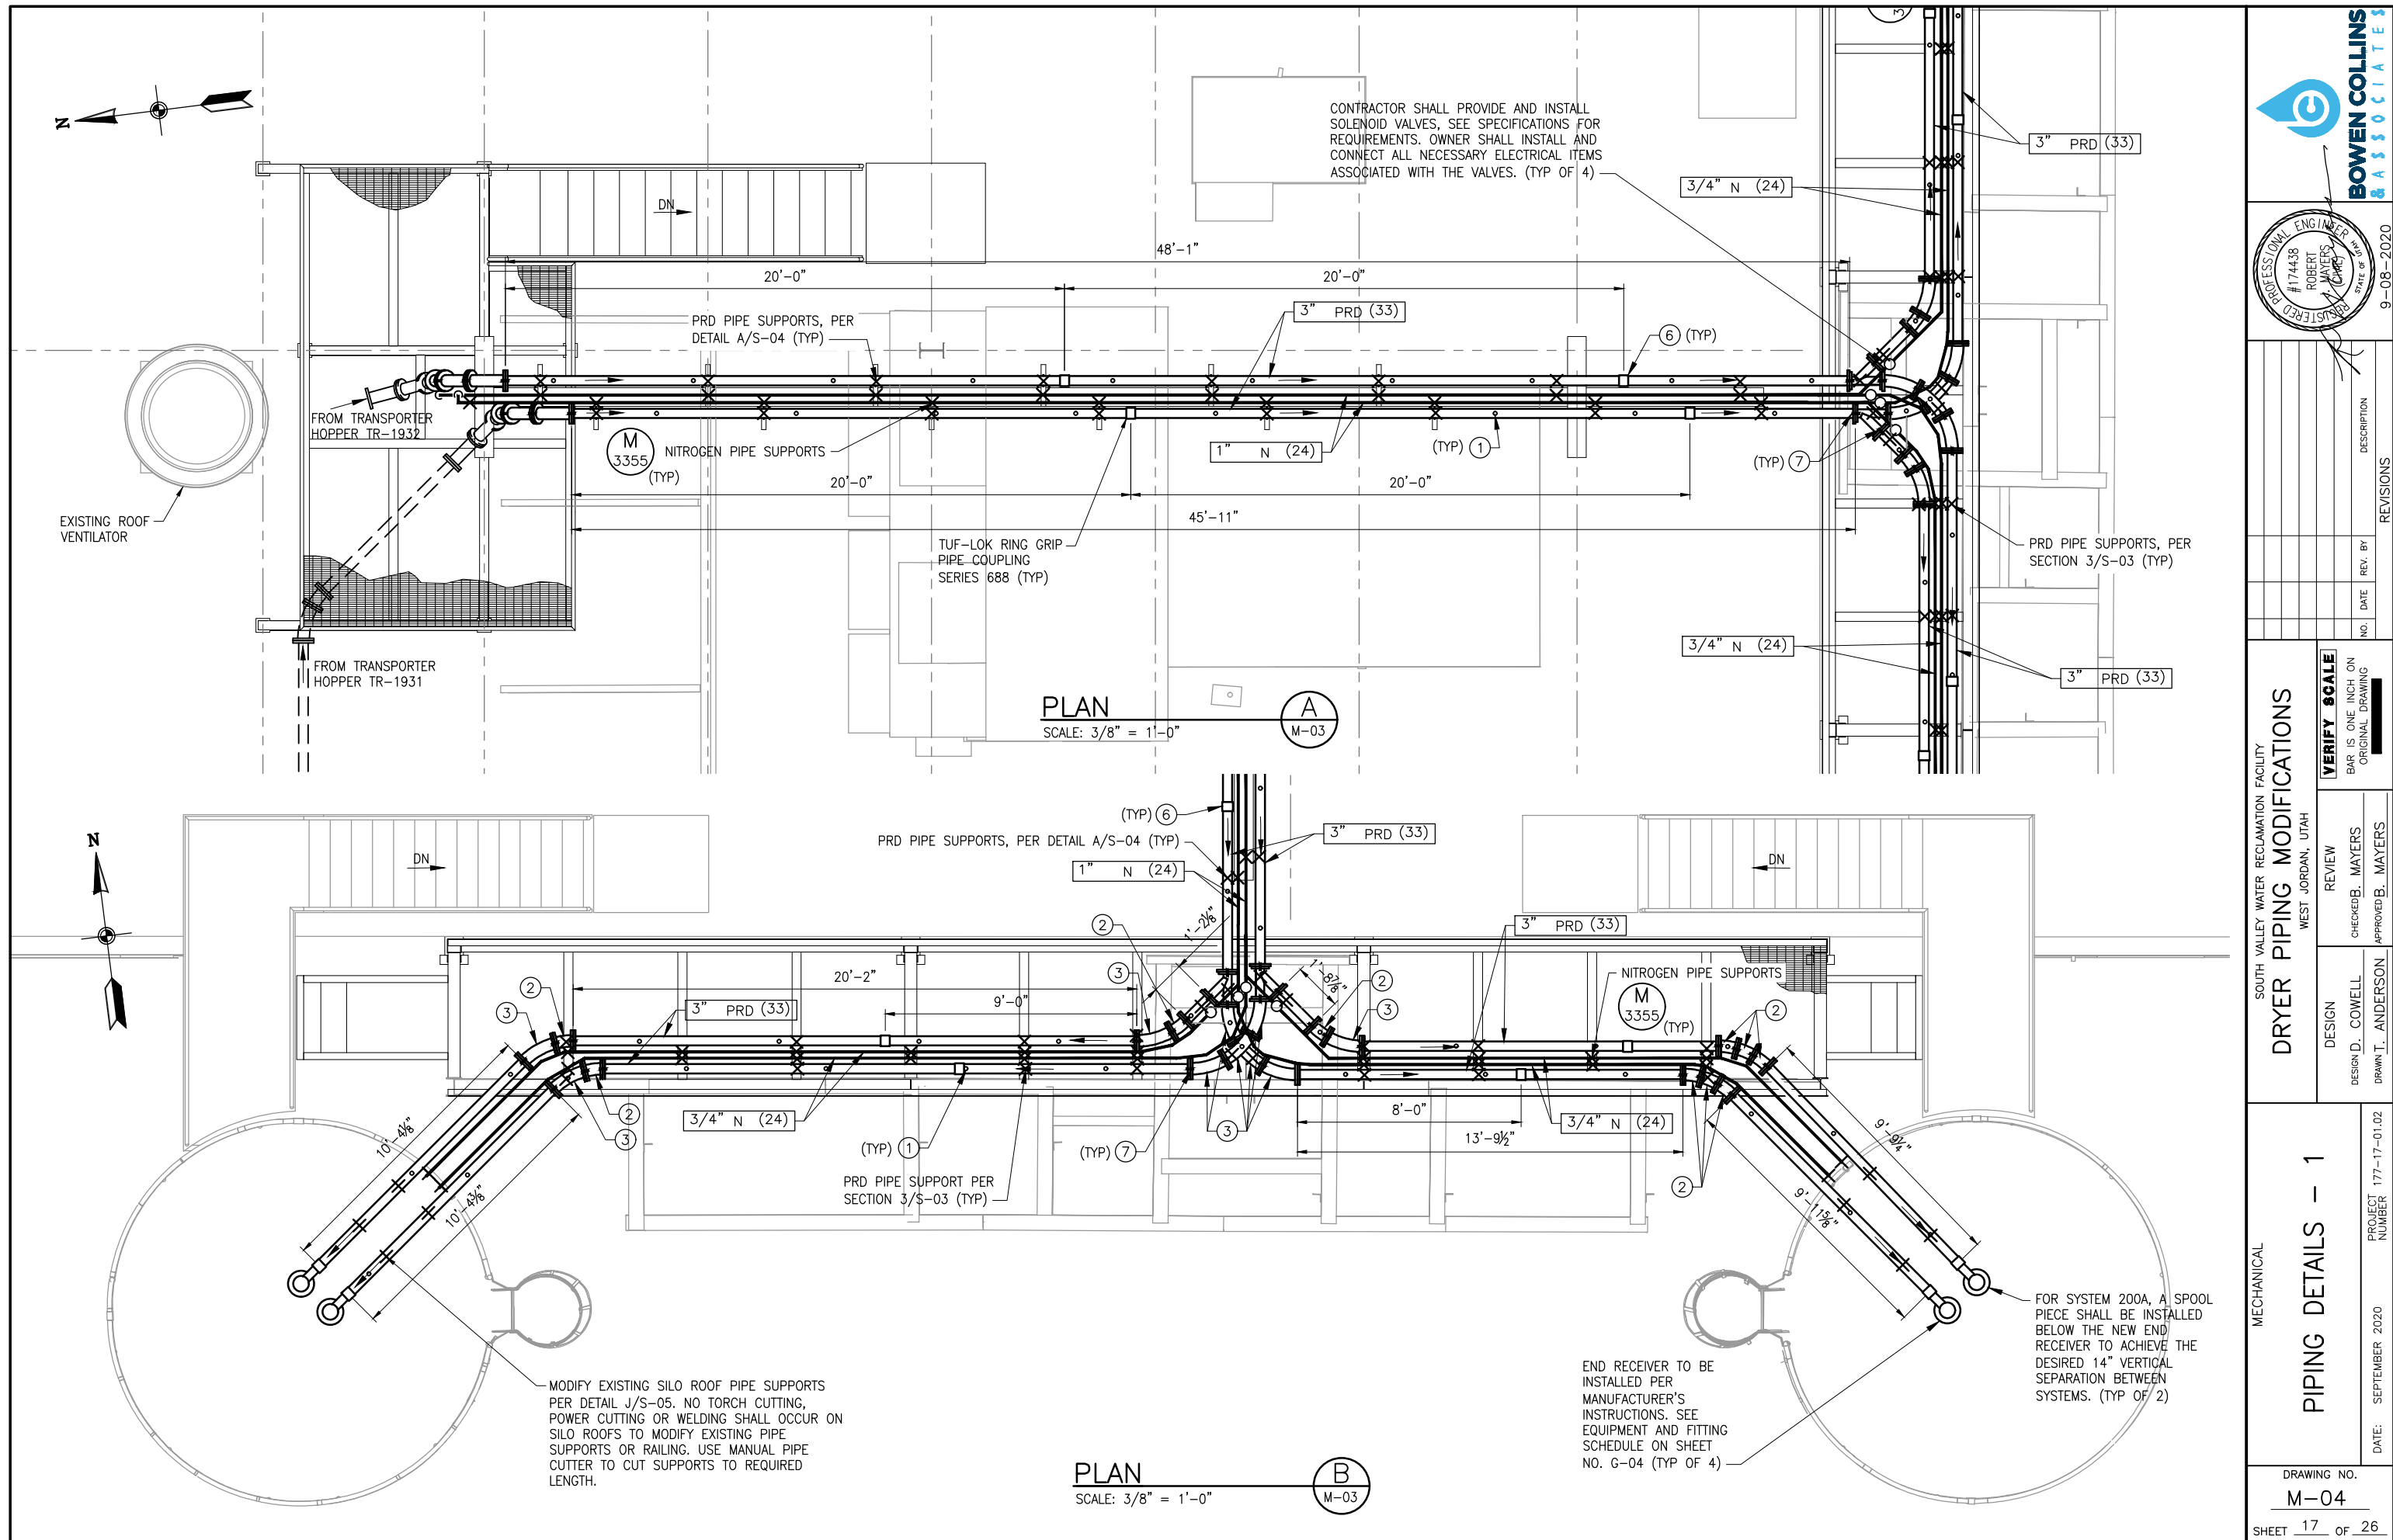


NO.	DATE	REV. BY	DESCRIPTION

VERIFY SCALE
BAR IS ONE INCH ON ORIGINAL DRAWING


REVIEW
CHECKED: B. MAYERS
APPROVED: B. MAYERS

DESIGN
DESIGN: D. COWELL
DRAWN: T. ANDERSON

MECHANICAL
DRYER PIPING MODIFICATIONS
PIPING DETAILS - 1
DATE: SEPTEMBER 2020
PROJECT NUMBER: 177-17-01.02

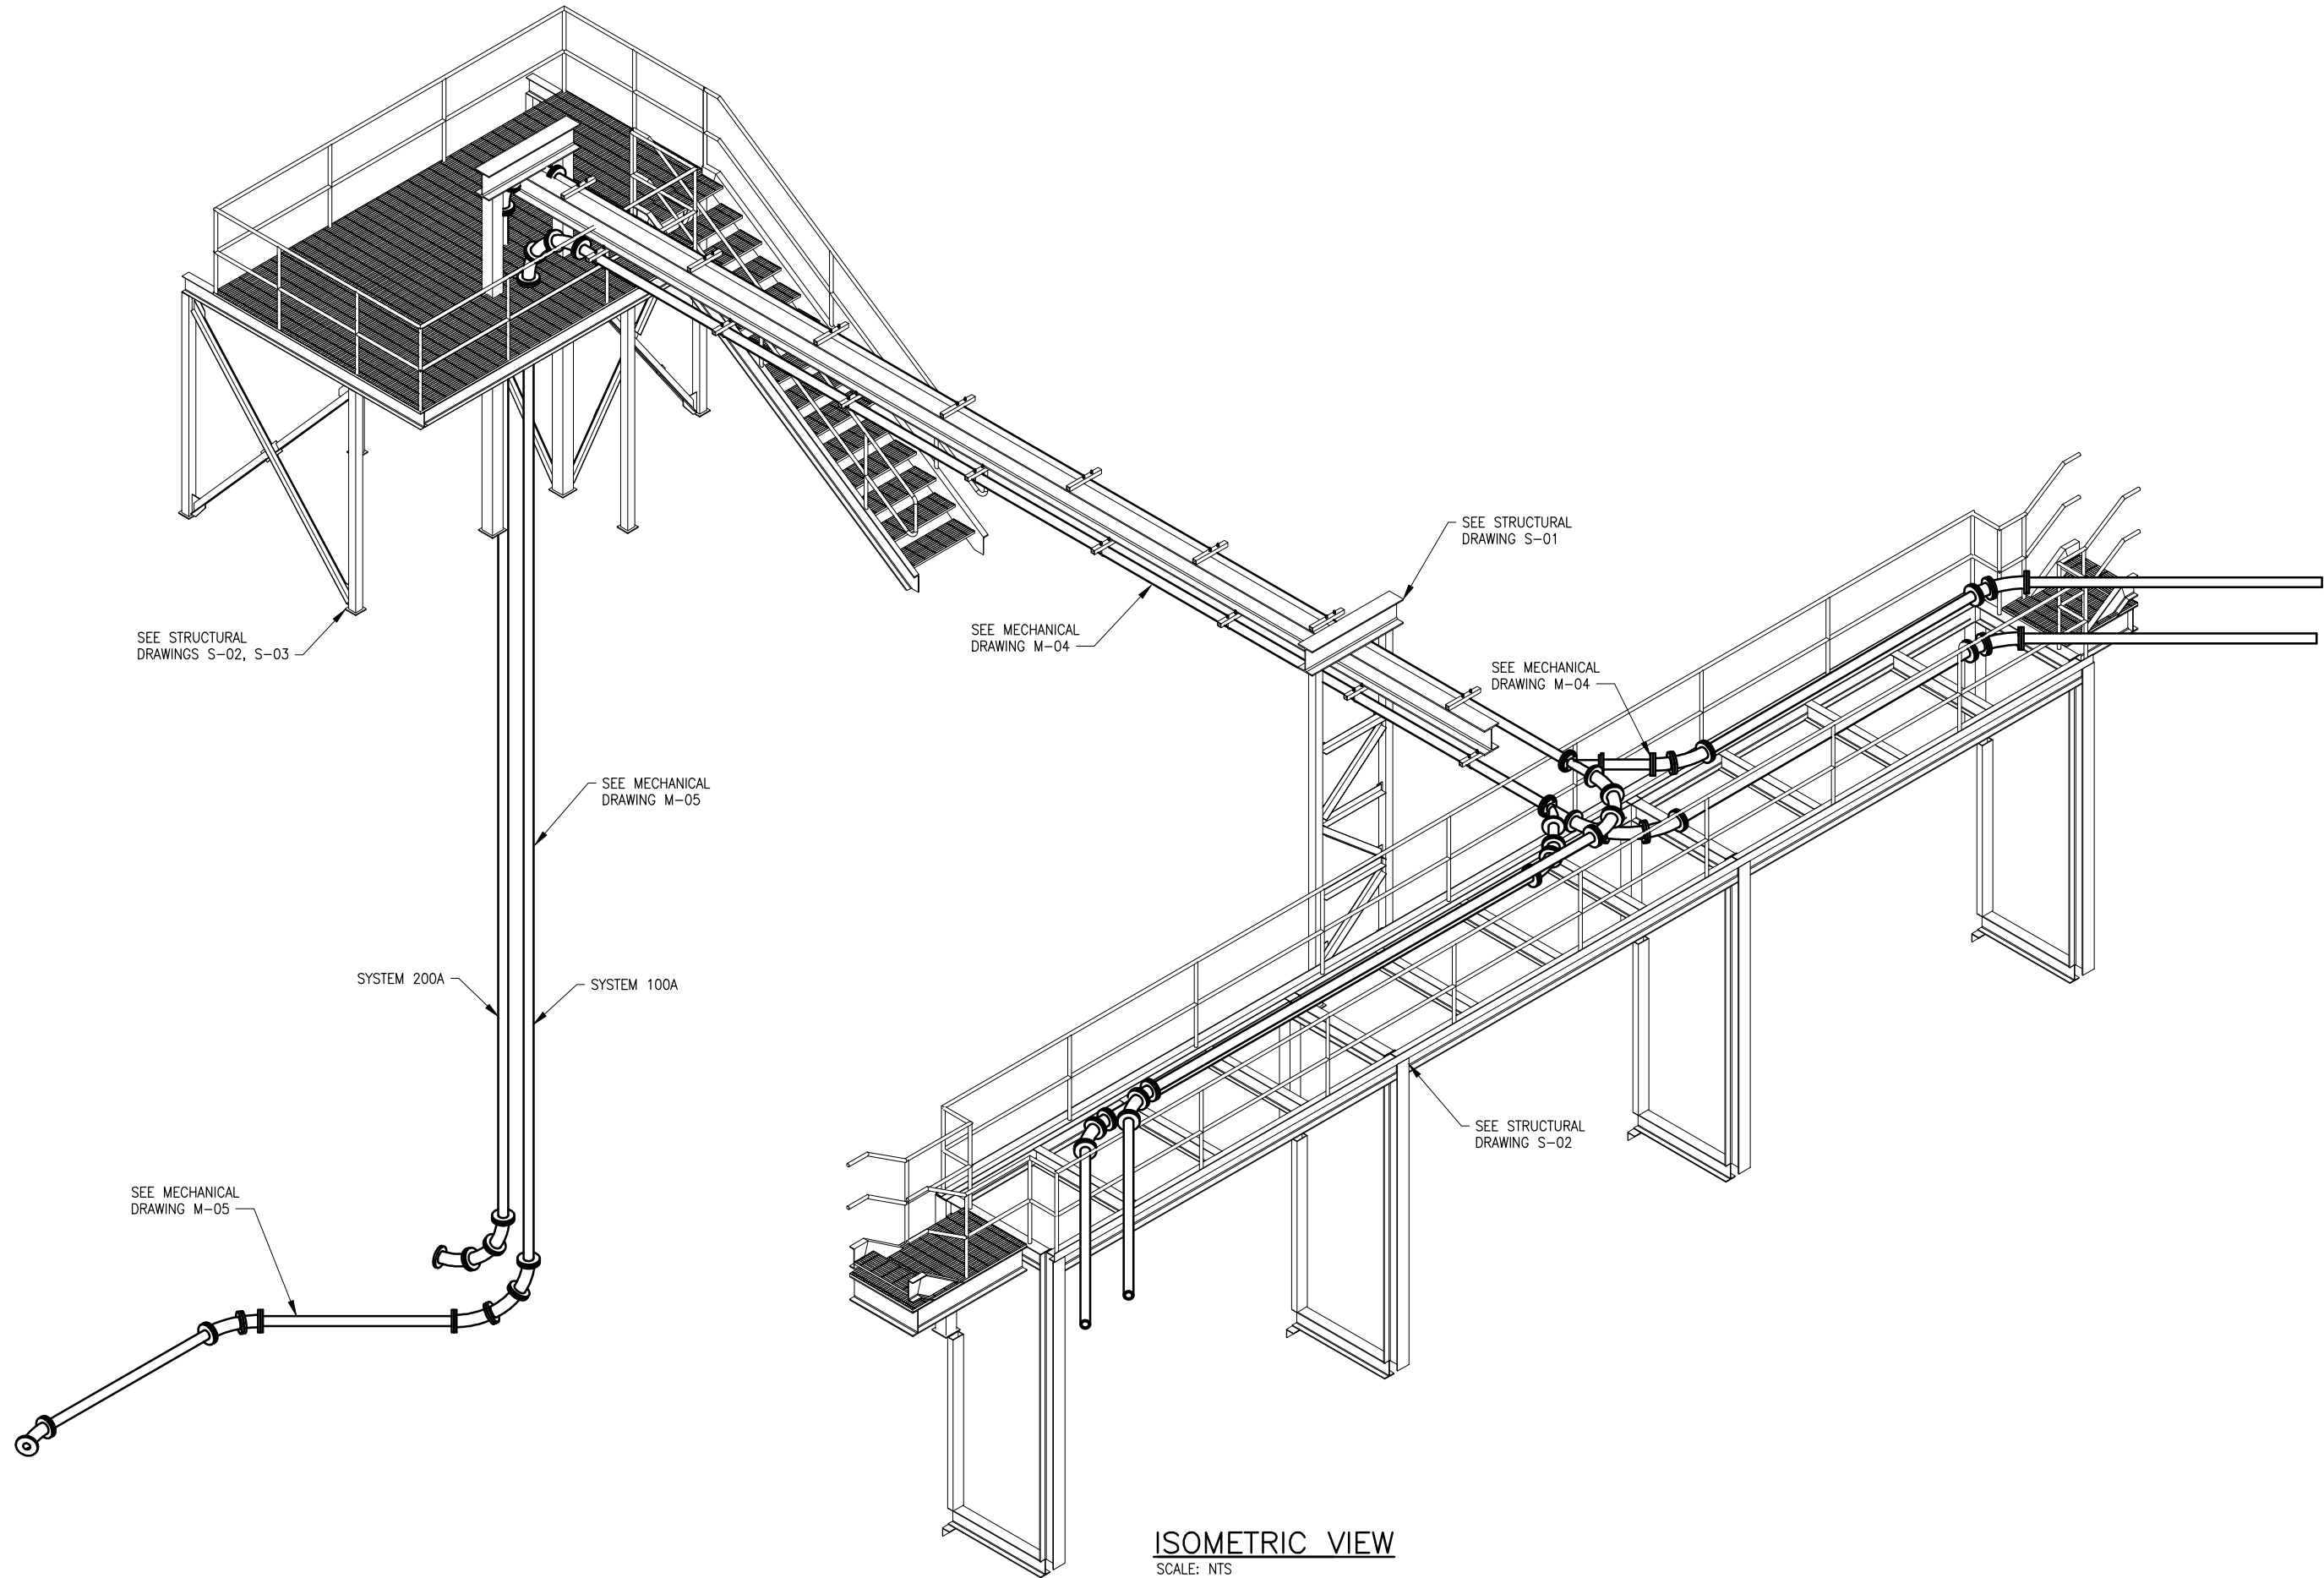

ISOMETRIC VIEW
SCALE: NTS

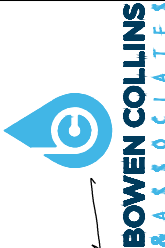

BOWEN COLLINS
ASSOCIATES



PROFESSIONAL ENGINEER
#174438
ROBERT MAYERS
STATE OF UTAH
9-08-2020

REVISIONS			
NO.	DATE	REV. BY	DESCRIPTION

SOUTH VALLEY WATER RECLAMATION FACILITY
WEST JORDAN, UTAH

DRYER PIPING MODIFICATIONS

DESIGN
DESIGN D. COWELL
DRAWN T. ANDERSON

REVIEW
CHECKED B. MAYERS
APPROVED B. MAYERS

VERIFY SCALE
BAR IS ONE INCH ON
ORIGINAL DRAWING

MECHANICAL

PIPING ISOMETRIC

DATE: SEPTEMBER 2020

PROJECT NUMBER 177-17-01.02

DRAWING NO.
M-06


SHEET 19 OF 26



1. EXISTING ROOFING IS "VERSIGARD" (VERISCO) 60 MIL. FULLY ADHERED SINGLE-PLY REINFORCED EPDM MEMBRANE SYSTEM INSTALLED IN 2008 WITH 20-YEAR TOTAL SYSTEM WARRANTY. REPAIR ROOFING PENETRATIONS FOR PIPING AND STRUCTURE PER MANUFACTURER REQUIREMENTS TO MAINTAIN WARRANTY AND PROVIDE EQUAL LEAK-TIGHT PERFORMANCE AND 90 MPH WIND UPLIFT RESISTANCE. INSULATION IS MECHANICALLY ATTACHED RIGID POLYISOCYANURATE. MATCH EXISTING MATERIALS, THICKNESSES, COMPONENTS, ADHESIVES, ATTACHMENTS, ETC. AS REQUIRED. PROVIDE MANUFACTURER RECOMMENDATIONS FOR THESE AND RELATED ITEMS AND INSTALLATION REQUIREMENTS FOR REVIEW PRIOR TO WORK PROCEEDING. PREVENT ENTRANCE OF MOISTURE, DEBRIS AND OTHER DELETERIOUS MATERIAL BENEATH MEMBRANE AND/OR THROUGH ROOF OPENING INTO BUILDING WHILE WORK IS PROCEEDING. WORK SHALL BE PERFORMED BY QUALIFIED AND EXPERIENCED ROOFING ORGANIZATION CERTIFIED BY THE MANUFACTURER FOR THIS INSTALLATION.



PIPE SUPPORT

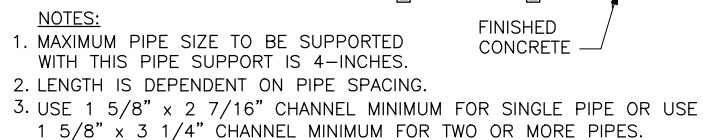

① REMOVE THE FLANGE PAINT TO ENSURE A COMPLETE GROUND BETWEEN FLANGES. IF STRANDED COPPER WIRE IS USED FOR BONDING STRAP, THEN PROVIDE AND INSTALL CRIMP-ON RING CONNECTORS ON EACH END OF WIRE.

#2 AWG STRANDED COPPER
WIRE WITH HMWPE INSULATION
OR 1-1/4" WIDE BY 1/16"
THICK, INSULATED, COPPER
STRAP. _____

[illegible]

SOUTH VALLEY WATER RECLAMATION FACILITY
DRYER PIPING MODIFICATIONS
WEST JORDAN, UTAH

VERIFY SCALE
BAR IS ONE INCH ON
ORIGINAL DRAWING

REVIEW	
CHECKED	B. MAYERS
APPROVED	B. MAYERS

DESIGN
DESIGN D. COWELL
RAWN T. ANDERSON

MECHANICAL DETAILS

DATE:	SEPTEMBER 2020	PROJECT NUMBER	177-17-01.02
-------	----------------	----------------	--------------

DRAWING NO.
GM-01

SHEET 22 OF 26

	SELECTOR SWITCH 2 POSITION		THERMAL OVERLOAD RELAY
	NORMALLY OPEN TIME DELAY CLOSING AFTER COIL ENERGIZED		SURGE PROTECTION DEVICE
	NORMALLY CLOSED TIME DELAY OPENING AFTER COIL ENERGIZED		DC BLOCKER
	INDICATOR LIGHT		DETAIL DESIGNATION
	REMOTE DEVICE CONNECTION		DETAIL CALL OUT
	CLOSED RELAY CONTACT		SHEET REFERENCE
	OPEN RELAY CONTACT		1'x4' LIGHT
	TERMINAL TO EXTERNAL REMOTE DEVICE		4' WALL MOUNT LIGHT
	WIRE TERMINAL OR CONNECTION POINT		EMERGENCY LIGHT (TWO HEADS)
	SINGLE PHASE MOTOR		LIGHT FIXTURE TYPE AS INDICATED
	MOTOR OVERLOAD RELAY		CONDUIT EXPOSED
	LIMIT SWITCH		CONDUIT RUN UNDERGROUND OR IN CONCRETE
	CONTROL RELAY		BARE COPPER WIRE IN SLAB OR UNDERGROUND GRID, SIZE AS NOTED
	TRANSFORMER		TRANSFORMER W/ DELTA-Y AND GROUND
	SELECTOR SWITCH 3 POSITION MAINTAINED CONTACT		UTILITY METER
	LEVEL SWITCH CLOSING ON FALLING LEVEL		UTILITY CT
	LEVEL SWITCH CLOSING ON RISING LEVEL		MOTOR, HORSEPOWER AS NOTED
	CONTROL SWITCH PUSHBUTTON, MOMENTARY CONTACT N.C.		CIRCUIT BREAKER
	GROUND CONNECTION		ELECTRICAL PANEL
	FRACTIONAL HP MOTOR		FUSE
	CONTROL STATION		MOTOR STARTER NEMA SIZE AS NOTED
	JUNCTION BOX		DISCONNECT SWITCH SIZE AS NOTED
	DUPLEX RECEPTACLE		RECEPTACLE
	COMBINATION MOTOR STARTER		PENDANT OR CEILING MOUNTED
	FUSED DISCONNECT		WALL MOUNTED FIXTURE
	SINGLE LIGHT SWITCH		POLE MOUNTED FIXTURE
	DISCONNECT UNFUSED SIZE NOTED		STANCHION MOUNTED FIXTURE
	CONTACTOR/STARTER (NO. OF POLES SHOWN)		ELECTRICAL CONNECTION
	CIRCUIT BREAKER (NO. OF POLES SHOWN)		
	SOLENOID		
	FLOW SWITCH CLOSING ON LOW FLOW		
	PRESSURE SWITCH CLOSING ON RISING PRESSURE		


GROUNDING	
	GROUND ROD
	GROUND ROD WITH GROUND WELL
	GROUND RISER FROM THE GROUND PLATE
	BOLTED AND WELDED GROUND CONNECTIONS, RESPECTIVELY
	GROUND CABLE:
	EMBEDDED IN CONCRETE
	BURIED IN EARTH
	EXPOSED

FUSE OR CB SIZE	SIZE (COPPER)
15	14
20	12
30	10
40	10
60	10
100	8
200	6
300	4
400	3
500	2
600	1
800	1/0
1000	2/0
1200	3/0
1600	4/0
2000	250
2500	350

COPPER CONDUCTOR	WIRE SIZE
#2 OR SMALLER	#8
1 OR 1/0	#6
2/0 OR 3/0	#4
>3/0 THRU 350 KCMIL	#2
>350 KCMIL THRU 600 KCMIL	1/0

FIXTURE SCHEDULE							
SYMBOL	DESCRIPTION	MANUFACTURER	CATALOG NO.	VA	LAMP	MOUNTING	NOTES
F1	HOLOPHANE, PETROLUX, LED, OUTDOOR LOCATION FIXTURE. AUTO SENSING VOLTAGE 120-277 VOLT. CLASS 2 DIVISION 1 LOCATION. WITH 1-1/2" NPT, STANCHION MOUNTING BRACKET. TYPE L1 OPTICS	HOLOPHANE	HPLED 42 700 4K AS US G L1 55C GD STANCHION MOUNT	98	LED	STANCHION	MOUNTING BRACKET PROVIDED WITH FIXTURE
F2	HOLOPHANE, PETROLUX, LED, OUTDOOR LOCATION FIXTURE. AUTO SENSING VOLTAGE 120-277 VOLT. CLASS 2 DIVISION 1 LOCATION. WITH 1-1/2" NPT, STANCHION MOUNTING BRACKET. TYPE L5 OPTICS	HOLOPHANE	HPLED 42 700 4K AS US G L5 55C GD STANCHION MOUNT	98	LED	STANCHION	MOUNTING BRACKET PROVIDED WITH FIXTURE

1. VERIFY ALL EQUIPMENT DIMENSIONS AND LOCATIONS BEFORE BEGINNING ROUGH-IN. CONSULT ALL APPLICABLE CONTRACT DRAWINGS AND SHOP DRAWINGS TO ENSURE NEC CODE CLEARANCE REQUIRED AROUND ALL ELECTRICAL EQUIPMENT.
2. CONTRACTOR SHALL VERIFY ALL ELECTRICAL LOADS (VOLTAGE, PHASE, CONNECTION REQUIREMENTS, ETC.) OF EQUIPMENT FURNISHED BEFORE BEGINNING ROUGH-IN.
3. SEE APPLICABLE SHOP DRAWINGS FOR ROUGH-IN LOCATION OF ALL EQUIPMENT, WIRING DEVICES, ETC.
4. THE ELECTRICAL CONTRACTOR SHALL NOTIFY AND COOPERATE WITH THE MECHANICAL CONTRACTOR SUCH THAT NO PIPING, OR EQUIPMENT FOREIGN TO THE OPERATION OF THE ELECTRICAL EQUIPMENT SHALL BE PERMITTED TO BE INSTALLED IN, ENTER OR PASS THROUGH ELECTRICAL ROOMS OR SPACES; OR ABOVE OR BELOW ELECTRICAL EQUIPMENT IN THE OTHER AREAS.
5. ALL PENETRATIONS OF FLOORS, WALLS AND CEILINGS SHALL BE SEALED WITH APPROVED MATERIAL.
6. FOR PACKAGE EQUIPMENT PROVIDED ON THE PROJECT, SOME CONDUITS AND WIRES ARE SHOWN ON THE DRAWINGS, BUT IT IS EXPECTED THAT SOME ADDITIONAL CONDUITS AND WIRES MAY BE REQUIRED BY EQUIPMENT MANUFACTURERS TO COMPLETE INSTALLATION. IT IS INCUMBENT UPON THE GENERAL CONTRACTOR TO COORDINATE THIS REQUIREMENT WITH HIS SUBCONTRACTORS TO MAKE SURE THAT EQUIPMENT SUPPLIER PROVIDED ALL NECESSARY ELECTRICAL INFORMATION TO ELECTRICAL SUBCONTRACTOR FOR INCLUSION WHETHER SHOWN OR NOT SHOWN ON THE DRAWINGS.
7. IF OTHER THAN FIRST NAMED EQUIPMENT IS USED, IT SHALL BE CAREFULLY CHECKED FOR ELECTRICAL REQUIREMENTS AND CONTROL REQUIREMENTS OF ALTERNATE EQUIPMENT. SHOULD CHANGES OR ADDITIONS OCCUR IN ELECTRICAL WORK, OR THE WORK OF OTHER CONTRACTORS BE REVISED BY THE ALTERNATE EQUIPMENT, THE COST OF ALL CHANGES SHALL BE THE RESPONSIBILITY OF THE ELECTRICAL CONTRACTOR.
8. IT IS THE ELECTRICAL SUBCONTRACTOR'S RESPONSIBILITY TO RECEIVE THE COMPLETE SET OF PLANS IN ORDER TO INSURE THAT ALL ITEMS RELATED TO ELECTRICAL POWER AND CONTROL SYSTEMS ARE COMPLETELY ACCOUNTED FOR.
9. ALL EQUIPMENT DIMENSIONS SHOWN ON PLANS AND ELEVATIONS ARE APPROXIMATE ONLY. THE CONTRACTOR SHALL USE THE SHOP DRAWINGS FOR PROPER LAYOUT, FOUNDATION AND PAD, ETC. FOR FINAL INSTALLATION WITHOUT ANY ADDITIONAL COST TO THE OWNER.
10. THE DRAWINGS GENERALLY ILLUSTRATE THE APPROXIMATE DESIRED LOCATION AND ARRANGEMENT OF OUTLETS, CONDUIT RUNS, EQUIPMENT AND OTHERS ITEMS. DETERMINE EXACT LOCATIONS IN THE FIELD BASED ON PHYSICAL SIZE AND ARRANGEMENT OF EQUIPMENT, FINISHED ELEVATIONS, EASEMENT LOCATIONS, AND OTHER OBSTRUCTIONS. LOCATIONS SHOWN ON THE DRAWINGS, HOWEVER, SHALL BE ADHERED TO AS CLOSELY AS POSSIBLE.
11. THE ELECTRICAL INSTALLATION SHALL COMPLY WITH THE CURRENT VERSION OF THE NEC, LOCAL, AND STATE CODES.

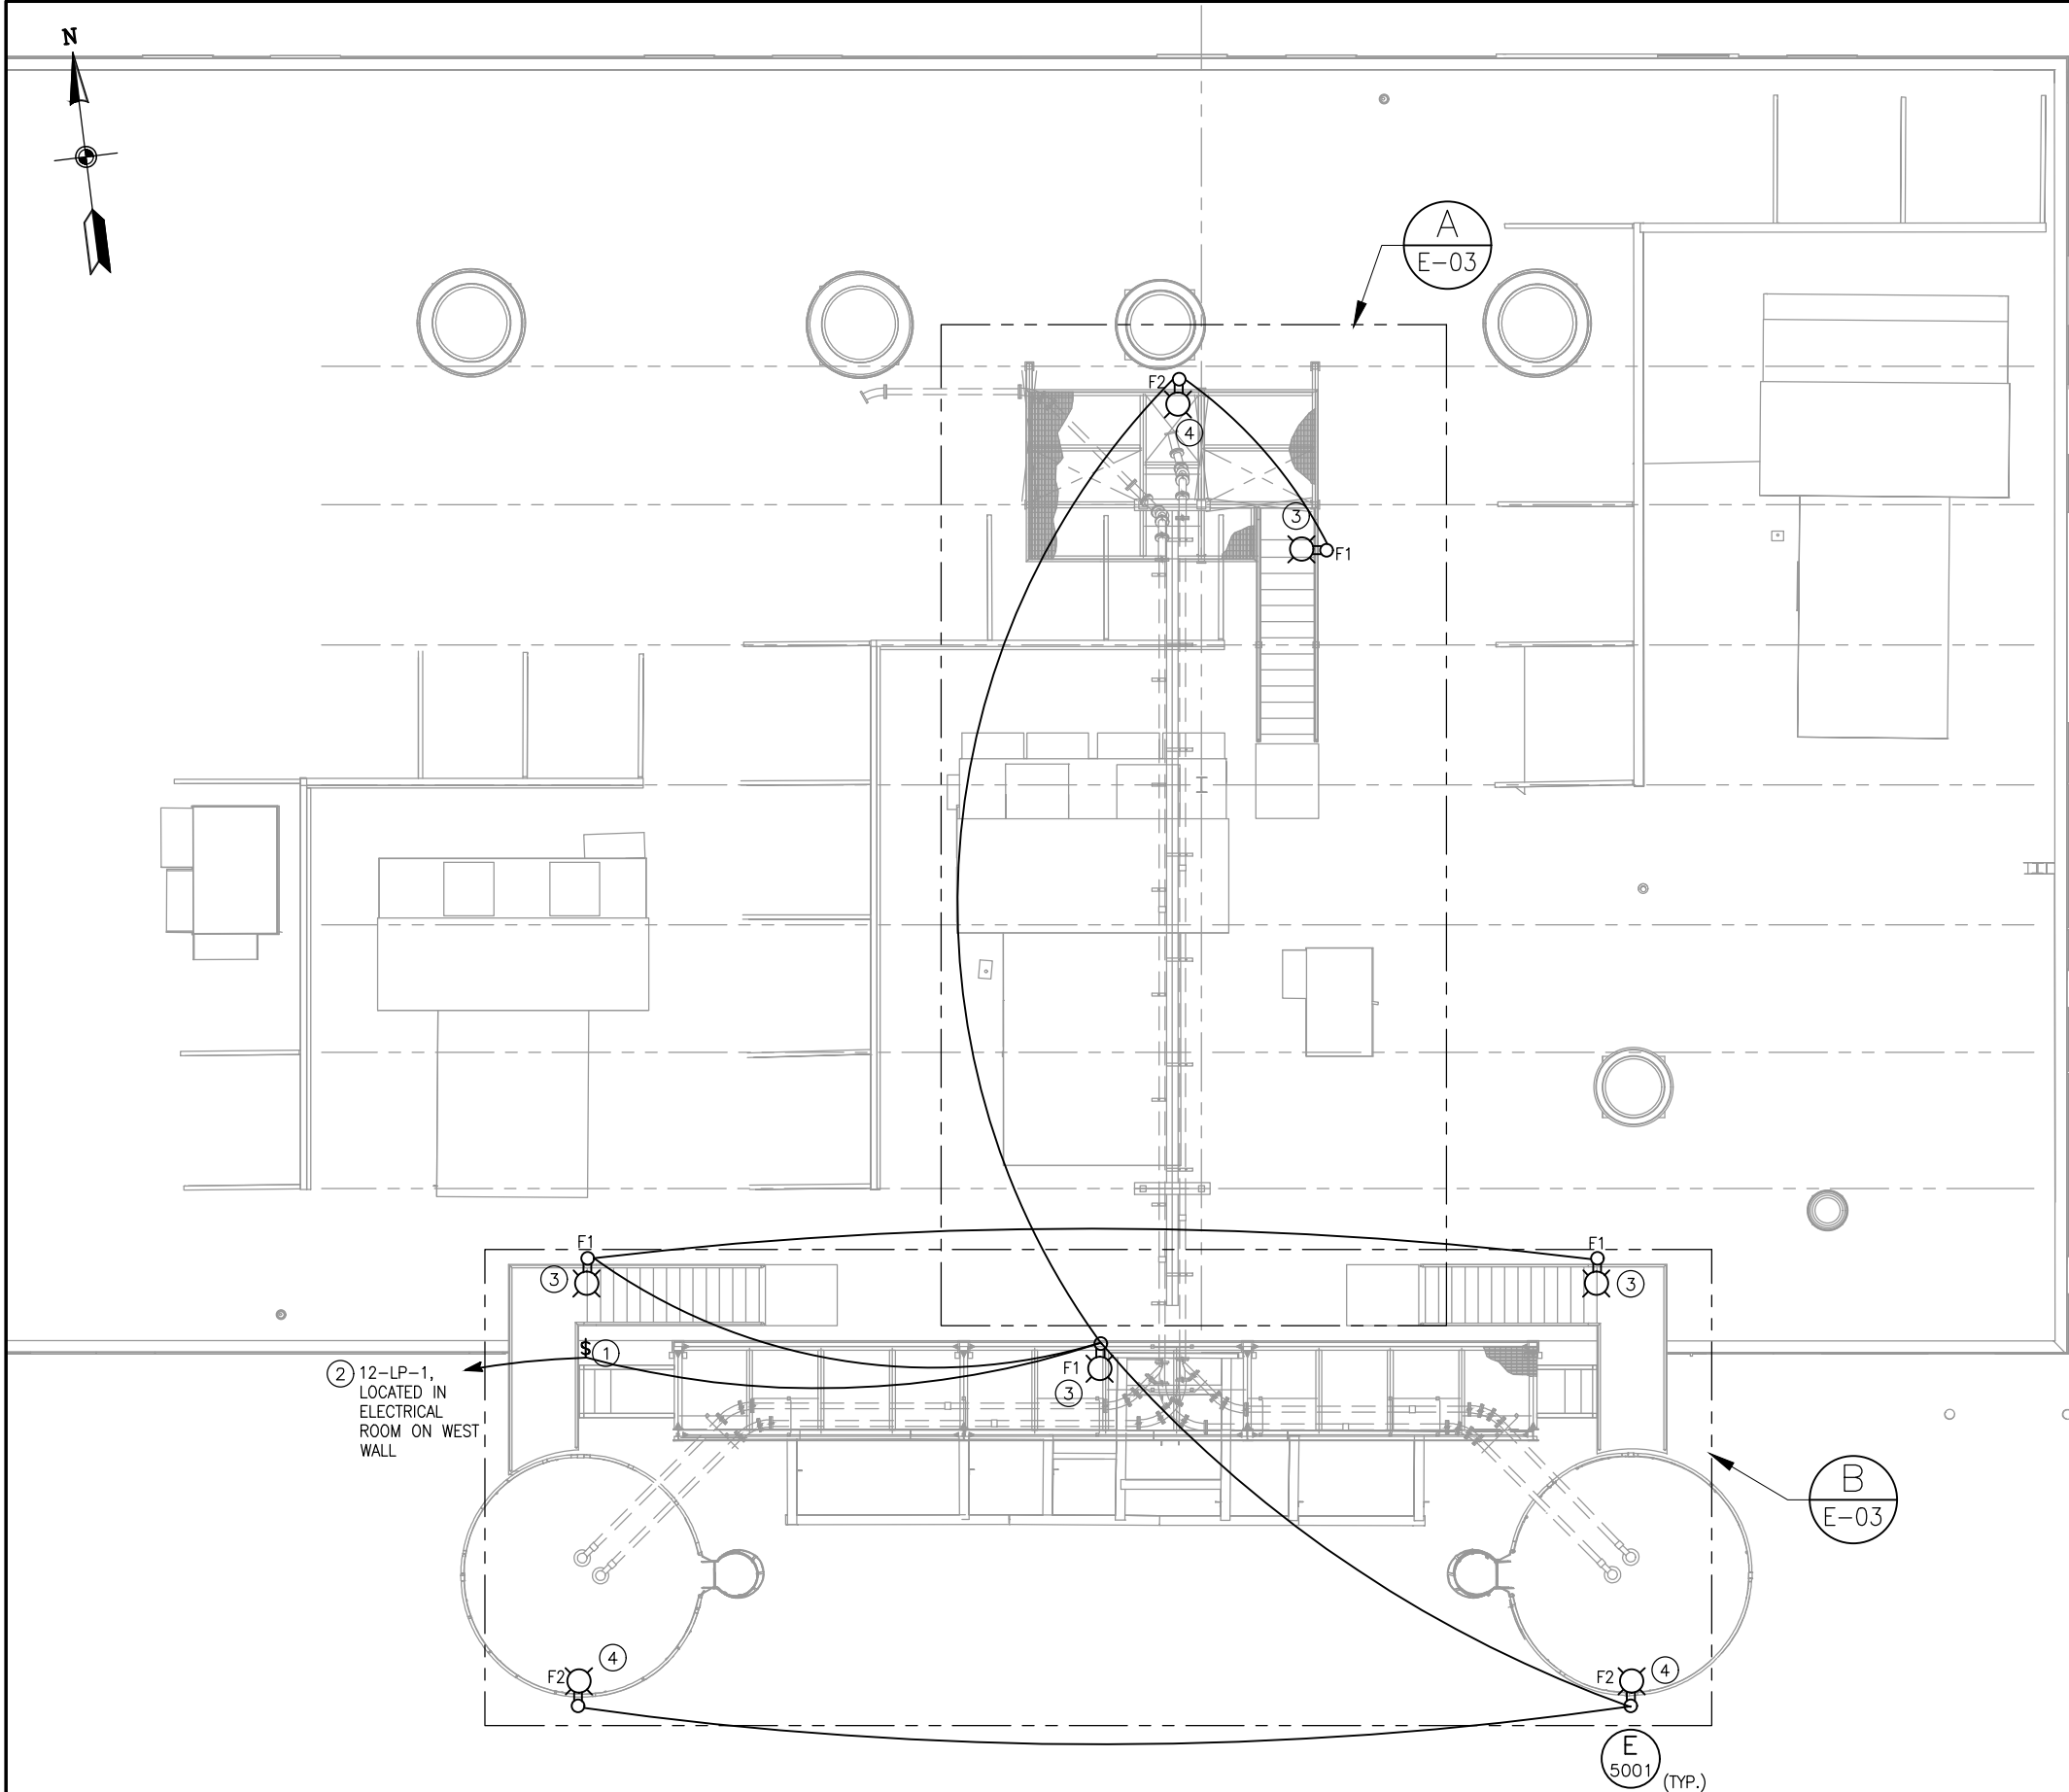


LIGHTING PLAN
SCALE: 3/16" = 1'-0"

- GENERAL NOTES:**
1. THE ELECTRICAL ITEMS, LIGHT FIXTURES, LIGHT SWITCH CONDUIT AND CONDUCTORS SHALL BE PROVIDED AND INSTALLED BY OWNER.
 2. THIS IS RATED AS A CLASS 2 DIVISION 1 HAZARDOUS AREA. LIGHT FIXTURES, LIGHT SWITCH AND CONDUIT INSTALLATION SHALL CONFORM TO NEC ARTICLE 502.
 3. REFER TO FIXTURE SCHEDULE ON DRAWING E-01 FOR FIXTURE INFORMATION, MANUFACTURER AND MODEL NUMBER.
 4. CONDUIT AND CONDUIT FITTINGS SHALL BE PVC COATED GALVANIZED RIGID STEEL.
 5. THE TOTAL LIGHTING LOAD IS APPROXIMATELY 5.7 AMPS.
 6. PROVIDE AND INSTALL A 20 AMP CIRCUIT BREAKER IN LIGHTING PANEL IN ELECTRICAL ROOM. THE PANEL IS LABELED 12-LP-1.

- KEY NOTES:**
- ① PROVIDE AND INSTALL SINGLE POLE, SINGLE THROW, 20 AMP LIGHT SWITCH IN A CLASS 2 DIVISION 1 HAZARDOUS ENCLOSURE. PROVIDE AND INSTALL A HAZARDOUS SEAL IN CONDUIT CLOSE TO SWITCH. SWITCH SHALL BE LOCATED AT TOP OF STAIRS FROM LOWER LEVEL.
 - ② PROVIDE AND INSTALL #12 AWG INSULATED CONDUCTORS, HOT, NEUTRAL AND GROUND.
 - ③ F1, STANCHION MOUNTED LIGHT FIXTURE MOUNTED WITH 1-1/2" PVC COATED GALVANIZED RIGID STEEL CONDUIT. PROVIDE AND INSTALL CONDUIT REDUCING FITTINGS WHERE NEEDED. FIXTURE SHALL BE MOUNTED APPROXIMATELY 8' ABOVE WALKWAY. THIS FIXTURE HAS A LONG NARROW TYPE L1 OPTICS.
 - ④ F2, STANCHION MOUNTED LIGHT FIXTURE MOUNTED WITH 1-1/2" PVC COATED GALVANIZED RIGID STEEL CONDUIT. PROVIDE AND INSTALL CONDUIT REDUCING FITTINGS WHERE NEEDED. FIXTURE SHALL BE MOUNTED APPROXIMATELY 8' ABOVE WALKWAY. THIS FIXTURE HAS A CIRCULAR TYPE L5 OPTICS.



BOWEN COLLINS ASSOCIATES

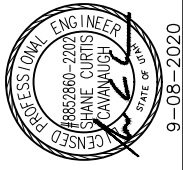

PROFESSIONAL ENGINEER
SHANE CURTIS CAVANAUGH
STATE OF UTAH
#8652860-2020
9-08-2020

REVISIONS			
NO.	DATE	REV. BY	DESCRIPTION

SOUTH VALLEY WATER RECLAMATION FACILITY
WEST JORDAN, UTAH

DRYER PIPING MODIFICATIONS

DESIGN	REVIEW	CHECKED	APPROVED
D. STEWART	S. CAVANAUGH	S. CAVANAUGH	S. CAVANAUGH

DESIGN D. STEWART
DRAWN T. ANDERSON

ELECTRICAL

LIGHTING PLAN AND LAYOUT

DATE: SEPTEMBER 2020
PROJECT NUMBER 177-17-01.02

DRAWING NO.
E-02

SHEET 24 OF 26

GENERAL NOTES:

- A. THE ELECTRICAL CONDUIT AND CONDUCTORS SHALL BE PROVIDED AND INSTALLED BY OWNER.
- B. THIS IS RATED AS A CLASS 2 DIVISION 1 HAZARDOUS AREA. CONDUIT AND CONDUCTOR INSTALLATION SHALL CONFORM TO NEC ARTICLE 502.
- C. CONDUIT AND CONDUIT FITTINGS SHALL BE PVC COATED GALVANIZED RIGID STEEL.

KEY NOTES:

1. THE SOLENOID VALVES SHALL BE 24 VOLTS DC, THEY SHALL BE WEATHER PROOF FOR THE OUTDOOR LOCATION AND RATED FOR A CLASS 2 DIVISION 1 HAZARDOUS AREA.
2. THE CONDUCTORS TO EACH SOLENOID VALVE FROM THE CONTROL PANELS AT EACH DYNAMIC AIR TRANSPORTER SHALL BE 2#12 AWG AND 1#12 AWG GROUND. EXISTING CONDUCTORS MAY BE REUSED OR NEW ONES INSTALLED. SOLENOID VALVES #1 AND #2 SHALL BE WIRED TO THE SYSTEM 100 ELECTRICAL CONTROL ENCLOSURE. SOLENOID VALVES #3 AND #4 SHALL BE WIRED TO THE SYSTEM 200 ELECTRICAL CONTROL ENCLOSURE. SEE VENDOR DRAWINGS FOR MORE INFORMATION REGARDING TERMINATION POINTS INSIDE SYSTEM CONTROL ENCLOSURES.
3. VENDOR SUPPLIED PNEUMATIC ACTUATED BUTTERFLY VALVES. EACH VALVE IS PROVIDED WITH A SOLENOID TO OPEN THE VALVE, A LIMIT SWITCH FOR VALVE OPEN INDICATION, A LIMIT SWITCH FOR VALVE CLOSED INDICATION, AND A PRESSURE SWITCH FOR VALVE SEALED INDICATION. OWNER TO PROVIDE AND INSTALL 5#12AWG AND 1#12AWG GROUND BETWEEN EACH BUTTERFLY VALVE AND ELECTRICAL CONTROL ENCLOSURE AND WIRE PER DETAIL E-5002. BFVA-1941 AND BFVB-1942 SHALL BE WIRED TO SYSTEM 100 ELECTRICAL CONTROL ENCLOSURE AT THE SYSTEM 100 DYNAMIC AIR TRANSPORTER. BFVA-1942 AND BFVB-1941 SHALL BE WIRED TO SYSTEM 200 ELECTRICAL CONTROL ENCLOSURE AT THE SYSTEM 200 DYNAMIC AIR TRANSPORTER. SEE VENDOR DRAWINGS FOR MORE INFORMATION REGARDING TERMINATION POINTS INSIDE SYSTEM CONTROL ENCLOSURES.

INSTRUMENTATION PLAN A
SCALE: 3/8" = 1'-0"

① ②
3/4" SOLENOID VALVES #1 AND #2


① ②
3/4" SOLENOID VALVES #3 AND #4

INSTRUMENTATION PLAN B
SCALE: 3/8" = 1'-0"

NO.	DATE	REV. BY	DESCRIPTION


SOUTH VALLEY WATER RECLAMATION FACILITY WEST JORDAN, UTAH	DESIGN D. STEWART T. ANDERSON	REVIEW S. CAVANAUGH S. CAVANAUGH	VERIFY SCALE BAR IS ONE INCH ON ORIGINAL DRAWING
	DRYER PIPING MODIFICATIONS		

ELECTRICAL	INSTRUMENTATION PLAN AND LAYOUT	DATE: SEPTEMBER 2020	PROJECT NUMBER: 177-17-01.02
		DRAWING NO. E-03	

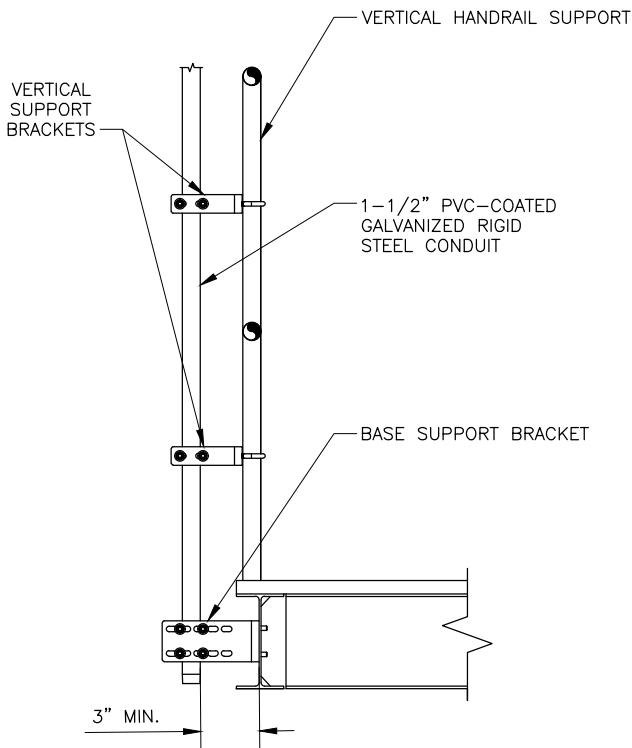

LIGHT POLE
MOUNTING DETAIL
SCALE: NTS

E
5001

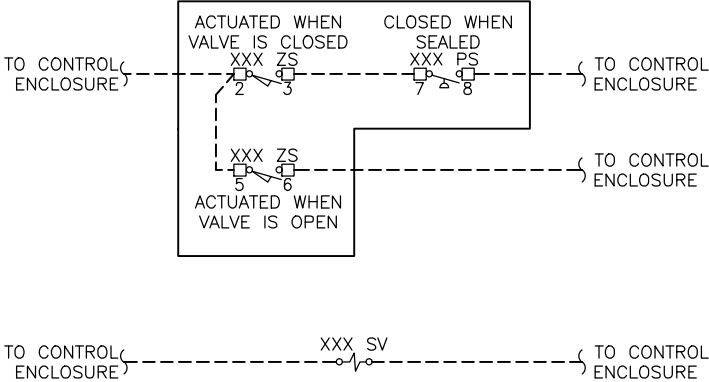

BUTTERFLY VALVE
CONTROLS WIRING
SCALE: NTS

E
5002

ELECTRICAL

ELECTRICAL DETAILS

DATE: SEPTEMBER 2020 PROJECT NUMBER 177-17-01.02

DRAWING NO.
GE-01

SHEET 26 OF 26

DRYER PIPING MODIFICATIONS

SOUTH VALLEY WATER RECLAMATION FACILITY
WEST JORDAN, UTAH

DESIGN
DESIGN D. STEWART
DRAWN T. ANDERSON

REVIEW
CHECKED S. CAVANAUGH
APPROVED S. CAVANAUGH

VERIFY SCALE
BAR IS ONE INCH ON
ORIGINAL DRAWING

REVISIONS			
NO.	DATE	REV. BY	DESCRIPTION

