

NO.	DATE	REV. BY	DESCRIPTION

DESIGN	DESIGN D. COWELL
VERIFY SCALE	BAR IS ONE INCH ON ORIGINAL DRAWING


REVIEW	CHECKED S. MEYER
APPROVED	APPROVED B. PACKER

DESIGN	DESIGN D. COWELL
VERIFY SCALE	BAR IS ONE INCH ON ORIGINAL DRAWING

PROJECT NUMBER	177-20-01
DATE	APRIL 2021

PROJECT	2A
SCREENING BUILDING	FLOOR PLAN ELEV. 4274.5

DRAWING NO.	RD-14
SHEET	37 OF 37

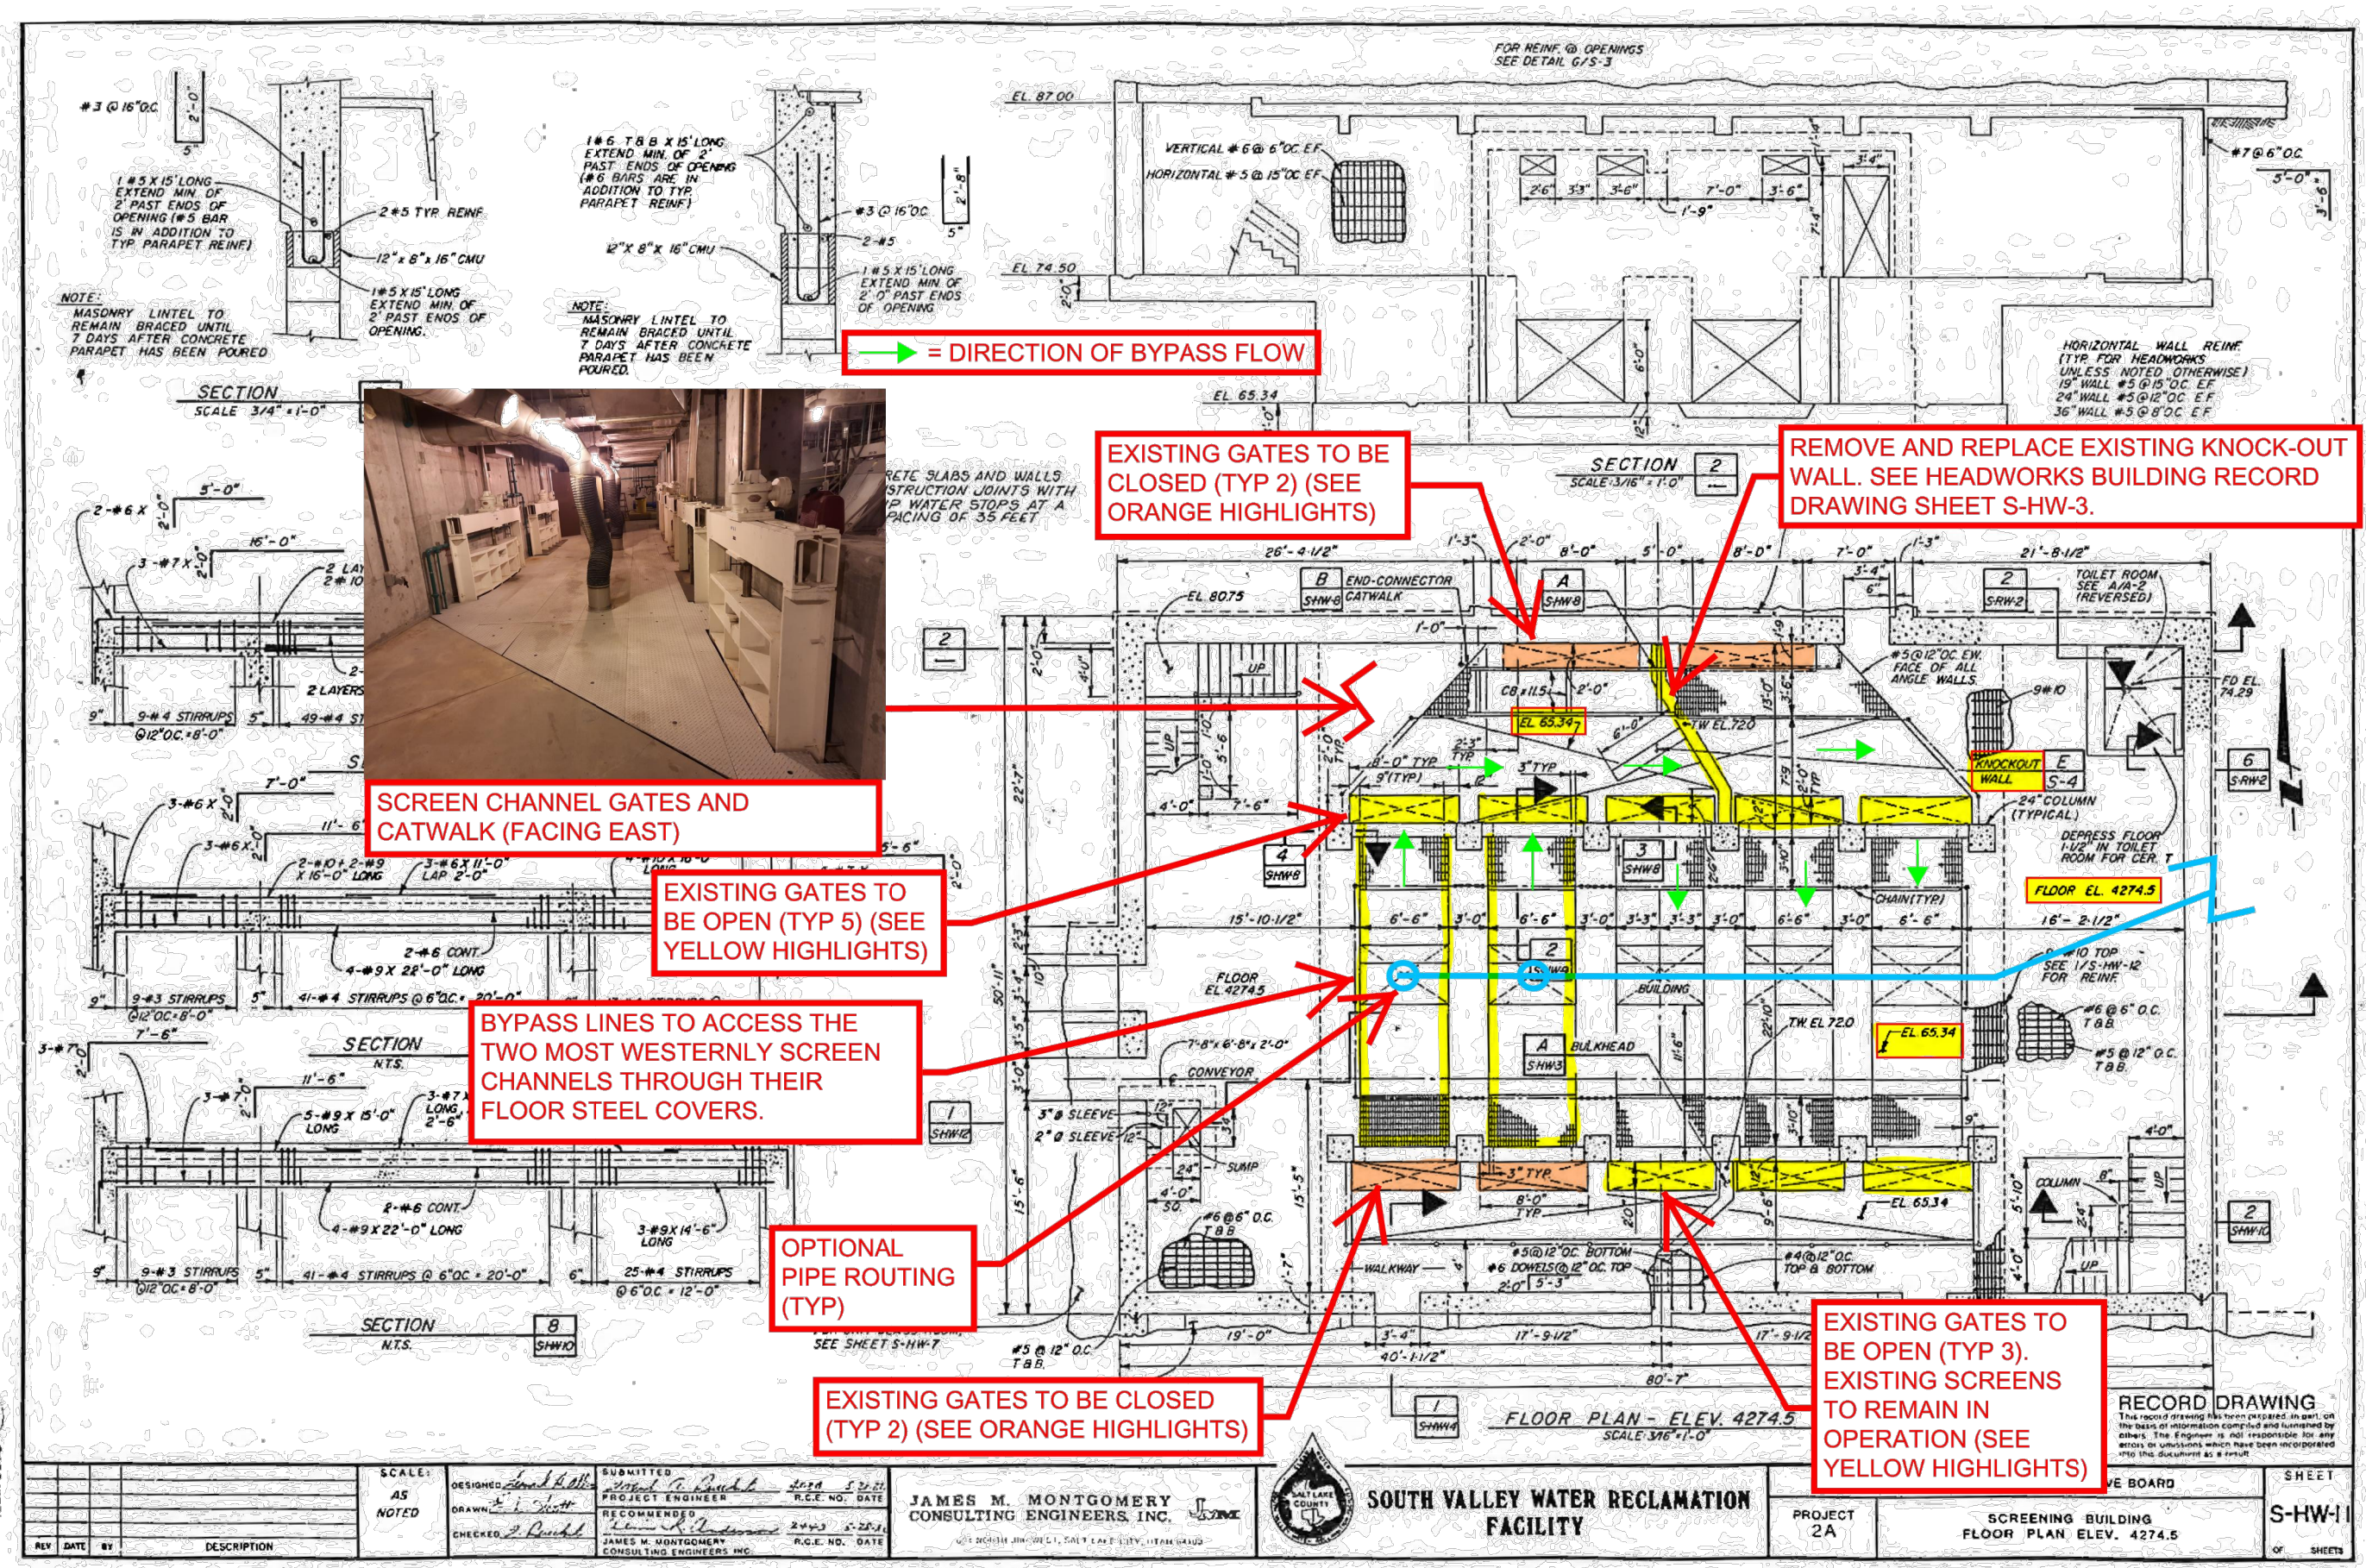

REV	DATE	BY	DESCRIPTION

SCALE	AS NOTED
DESIGNED	James M. Montgomery
DRAWN	James M. Montgomery
CHECKED	James M. Montgomery

SUBMITTED	James M. Montgomery	DATE	4/8/21
PROJECT ENGINEER	James M. Montgomery	R.E. NO.	
RECOMMENDED	James M. Montgomery	DATE	4/8/21
		R.E. NO.	

JAMES M. MONTGOMERY CONSULTING ENGINEERS, INC.	
405 SOUTH JORDAN BLVD., SUITE 100, WEST JORDAN, UT 84086	

SOUTH VALLEY WATER RECLAMATION FACILITY	
SCREENING BUILDING FLOOR PLAN ELEV. 4274.5	

PROJECT	2A
SHEET	S-HW-11